



Chick-fil-A

Chick-fil-A  
5200 Buffington Road  
Atlanta, Georgia 30349-2998

INTERPLAN

ARCHITECTURE  
ENGINEERING  
INTERIOR DESIGN  
PROJECT MANAGEMENT

604 COURTLAND STREET  
SUITE 100  
ORLANDO, FLORIDA 32804  
PH 407.645.5008  
FX 407.629.9124

SEAL:  
UNLESS THE WORDS "NOT FOR CONSTRUCTION"  
SIGNATURE AND SEAL APPEAR BELOW:

CHICK-FIL-A  
Cherokee Place, FSR  
115 Cherokee Place, Cartersville, GA  
30121

FSR# 00534

REVISION SCHEDULE  
NO. DATE DESCRIPTION

1 01.04.18 DIR COMMENTS

CONSULTANT PROJECT # 2017.0149  
PRINTED FOR Bld  
DATE 11.20.17  
DRAWN BY MB


SHEET  
ELECTRICAL PLAN-OMD  
CANOPY

SHEET NUMBER

E-223


## MEAL DELIVERY CANOPY POWER PLAN

1/4" = 1'-0"

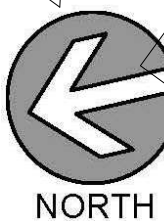


### ELECTRICAL KEYNOTES (NEW BUILDING)

- CEILING LIGHT PROVIDED BY CANOPY SUPPLIER AND INSTALLED BY E.C.
- NOT USED.
- AIR CIRCULATING FAN WITH INTEGRAL ON-OFF SWITCH PROVIDED BY OTHERS.
- NOT USED.
- THRU (1) NOT USED.
- AT NEW BUILDINGS INSTALL UNDERGROUND 3" SCH40 PVC CONDUIT UP INTO THE CANOPY COLUMN WITH TYPE MC CABLE (GALVANIZED STEEL WITH PVC JACKET) RUN WITHIN FOR THE 120V POWER FOR LIGHTS, 120 VOLT POWER FOR FANS, AND 24 VOLT POWER FOR THE INFARED GAS HEATERS.
- NOT USED.
- PROVIDE ONE DUPLEX GFCI WITH IN-HOUSE WP COVER PLATE AND THREE 120V SINGLE-POLE SWITCHES (EACH WITH HUBBELL #RW51550 WP COVER PLATE) MOUNTED ON THE COLUMN IN FLUSH MOUNTED METAL SINGLE GANG BOXES FOR LOCAL ON-OFF CONTROL OF THE FAN, HEATERS, AND CANOPY LIGHTS. SEE WIRING SCHEMATIC AND CANOPY COLUMN DETAILS FOR FURTHER INFORMATION. ALL SURFACE MOUNTED ITEMS AND COVER PLATES TO BE FIELD PAINTED MATTE BLACK.
- ALL CONDUIT AND BOXES SHALL BE CONCEALED FROM NORMAL VIEW, UNDERGROUND, IN COLUMNS, OR ABOVE THE CANOPY (ON THE ROOF). MC CABLE (GALVANIZED STEEL WITH PVC JACKET) TO BE USED INSIDE THE COLUMNS, BUT MUST CONVERT BACK TO IMC ABOVE THE ROOF. REFER TO THE MECHANICAL DRAWINGS FOR DETAILS OF MOUNTING CONDUIT ON THE ROOF OF THE CANOPY. ALL EXPOSED ELECTRICAL BOXES TO BE NEMA 3R CAST-METAL.

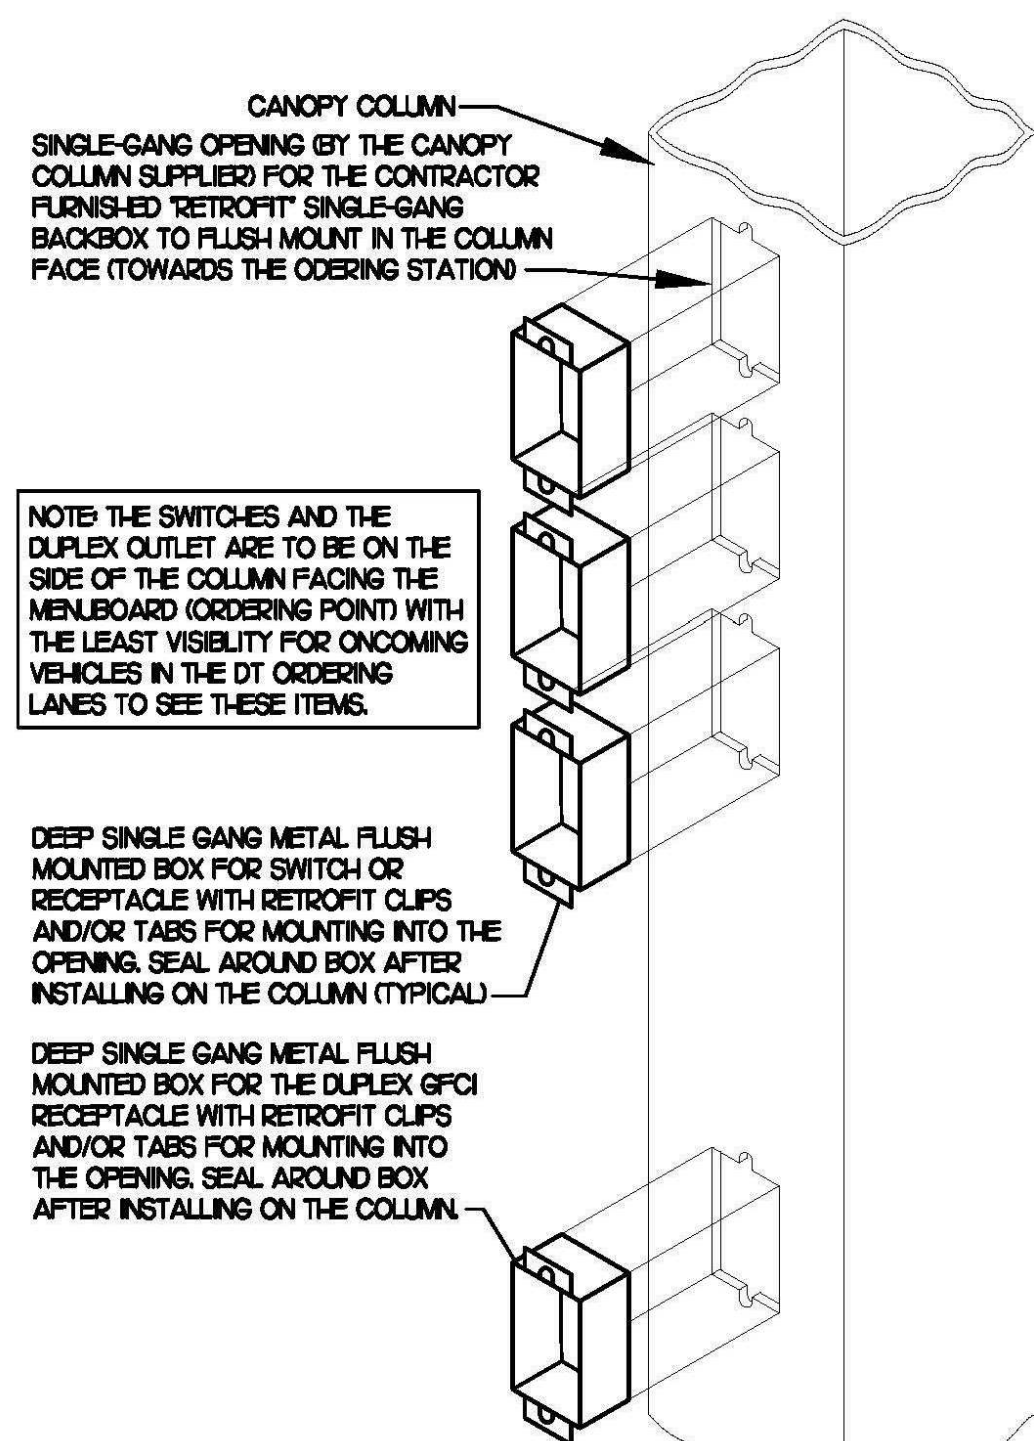


### CANOPY COLUMN ISOMETRIC

NOT TO SCALE

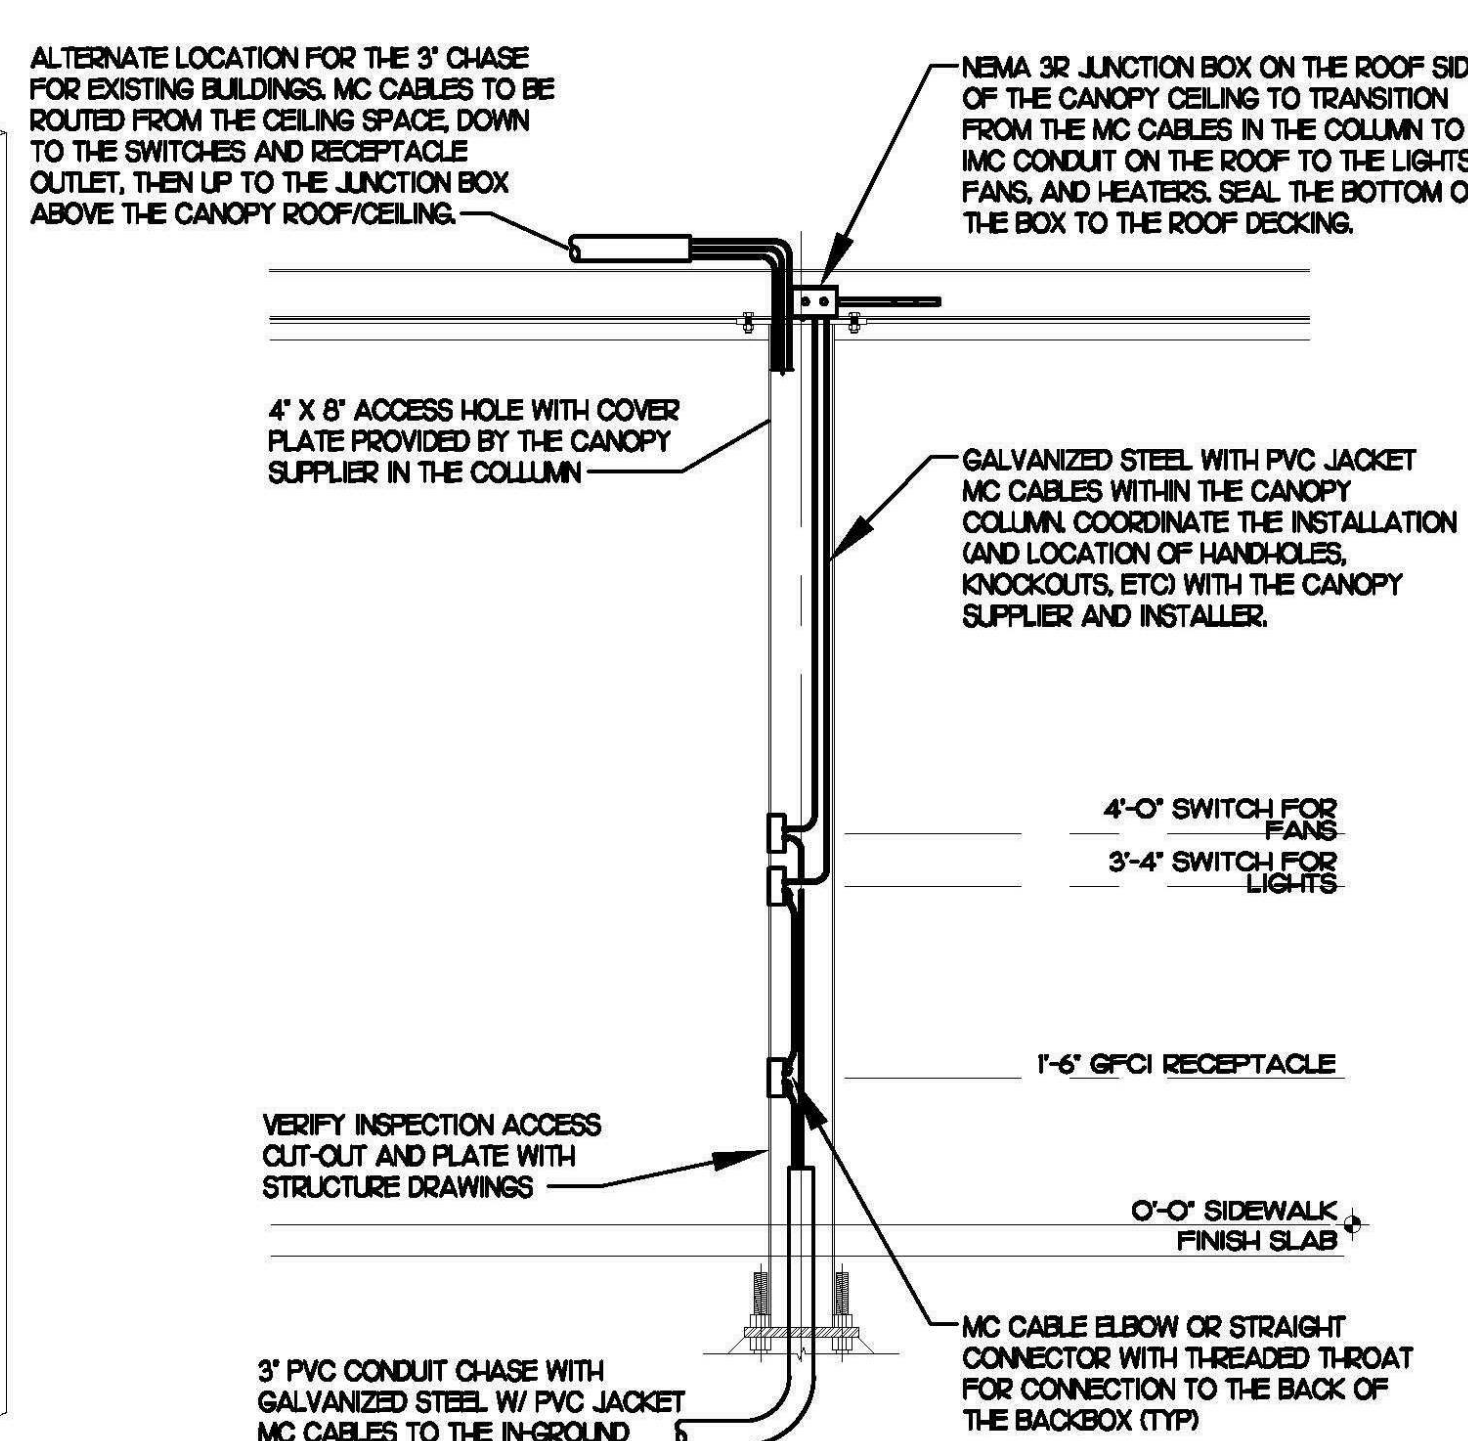

### SECTION - CANOPY COLUMN

NOT TO SCALE

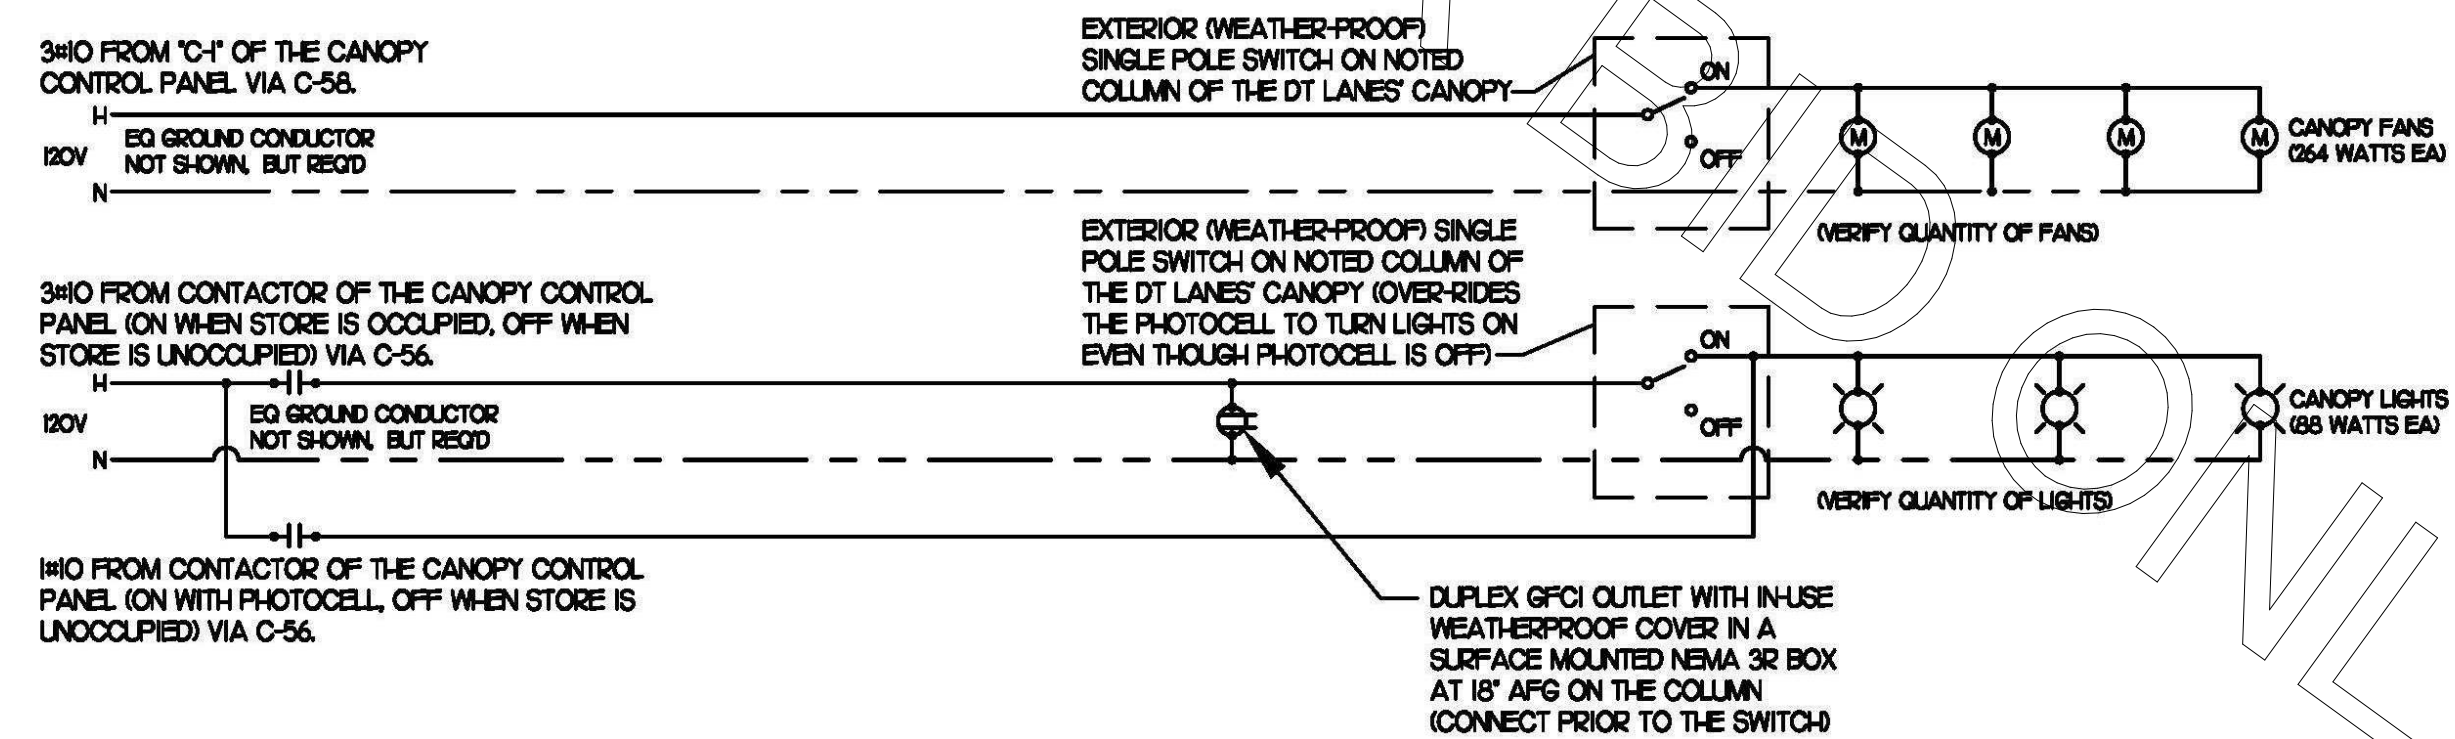

### MEAL DELIVERY CANOPY POWER WIRING SCHEMATIC

NO SCALE